
 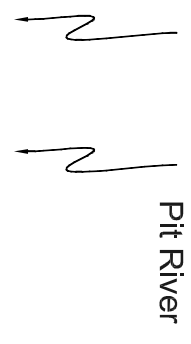



Pit River Diversion Dam # 4 FERC Project 233

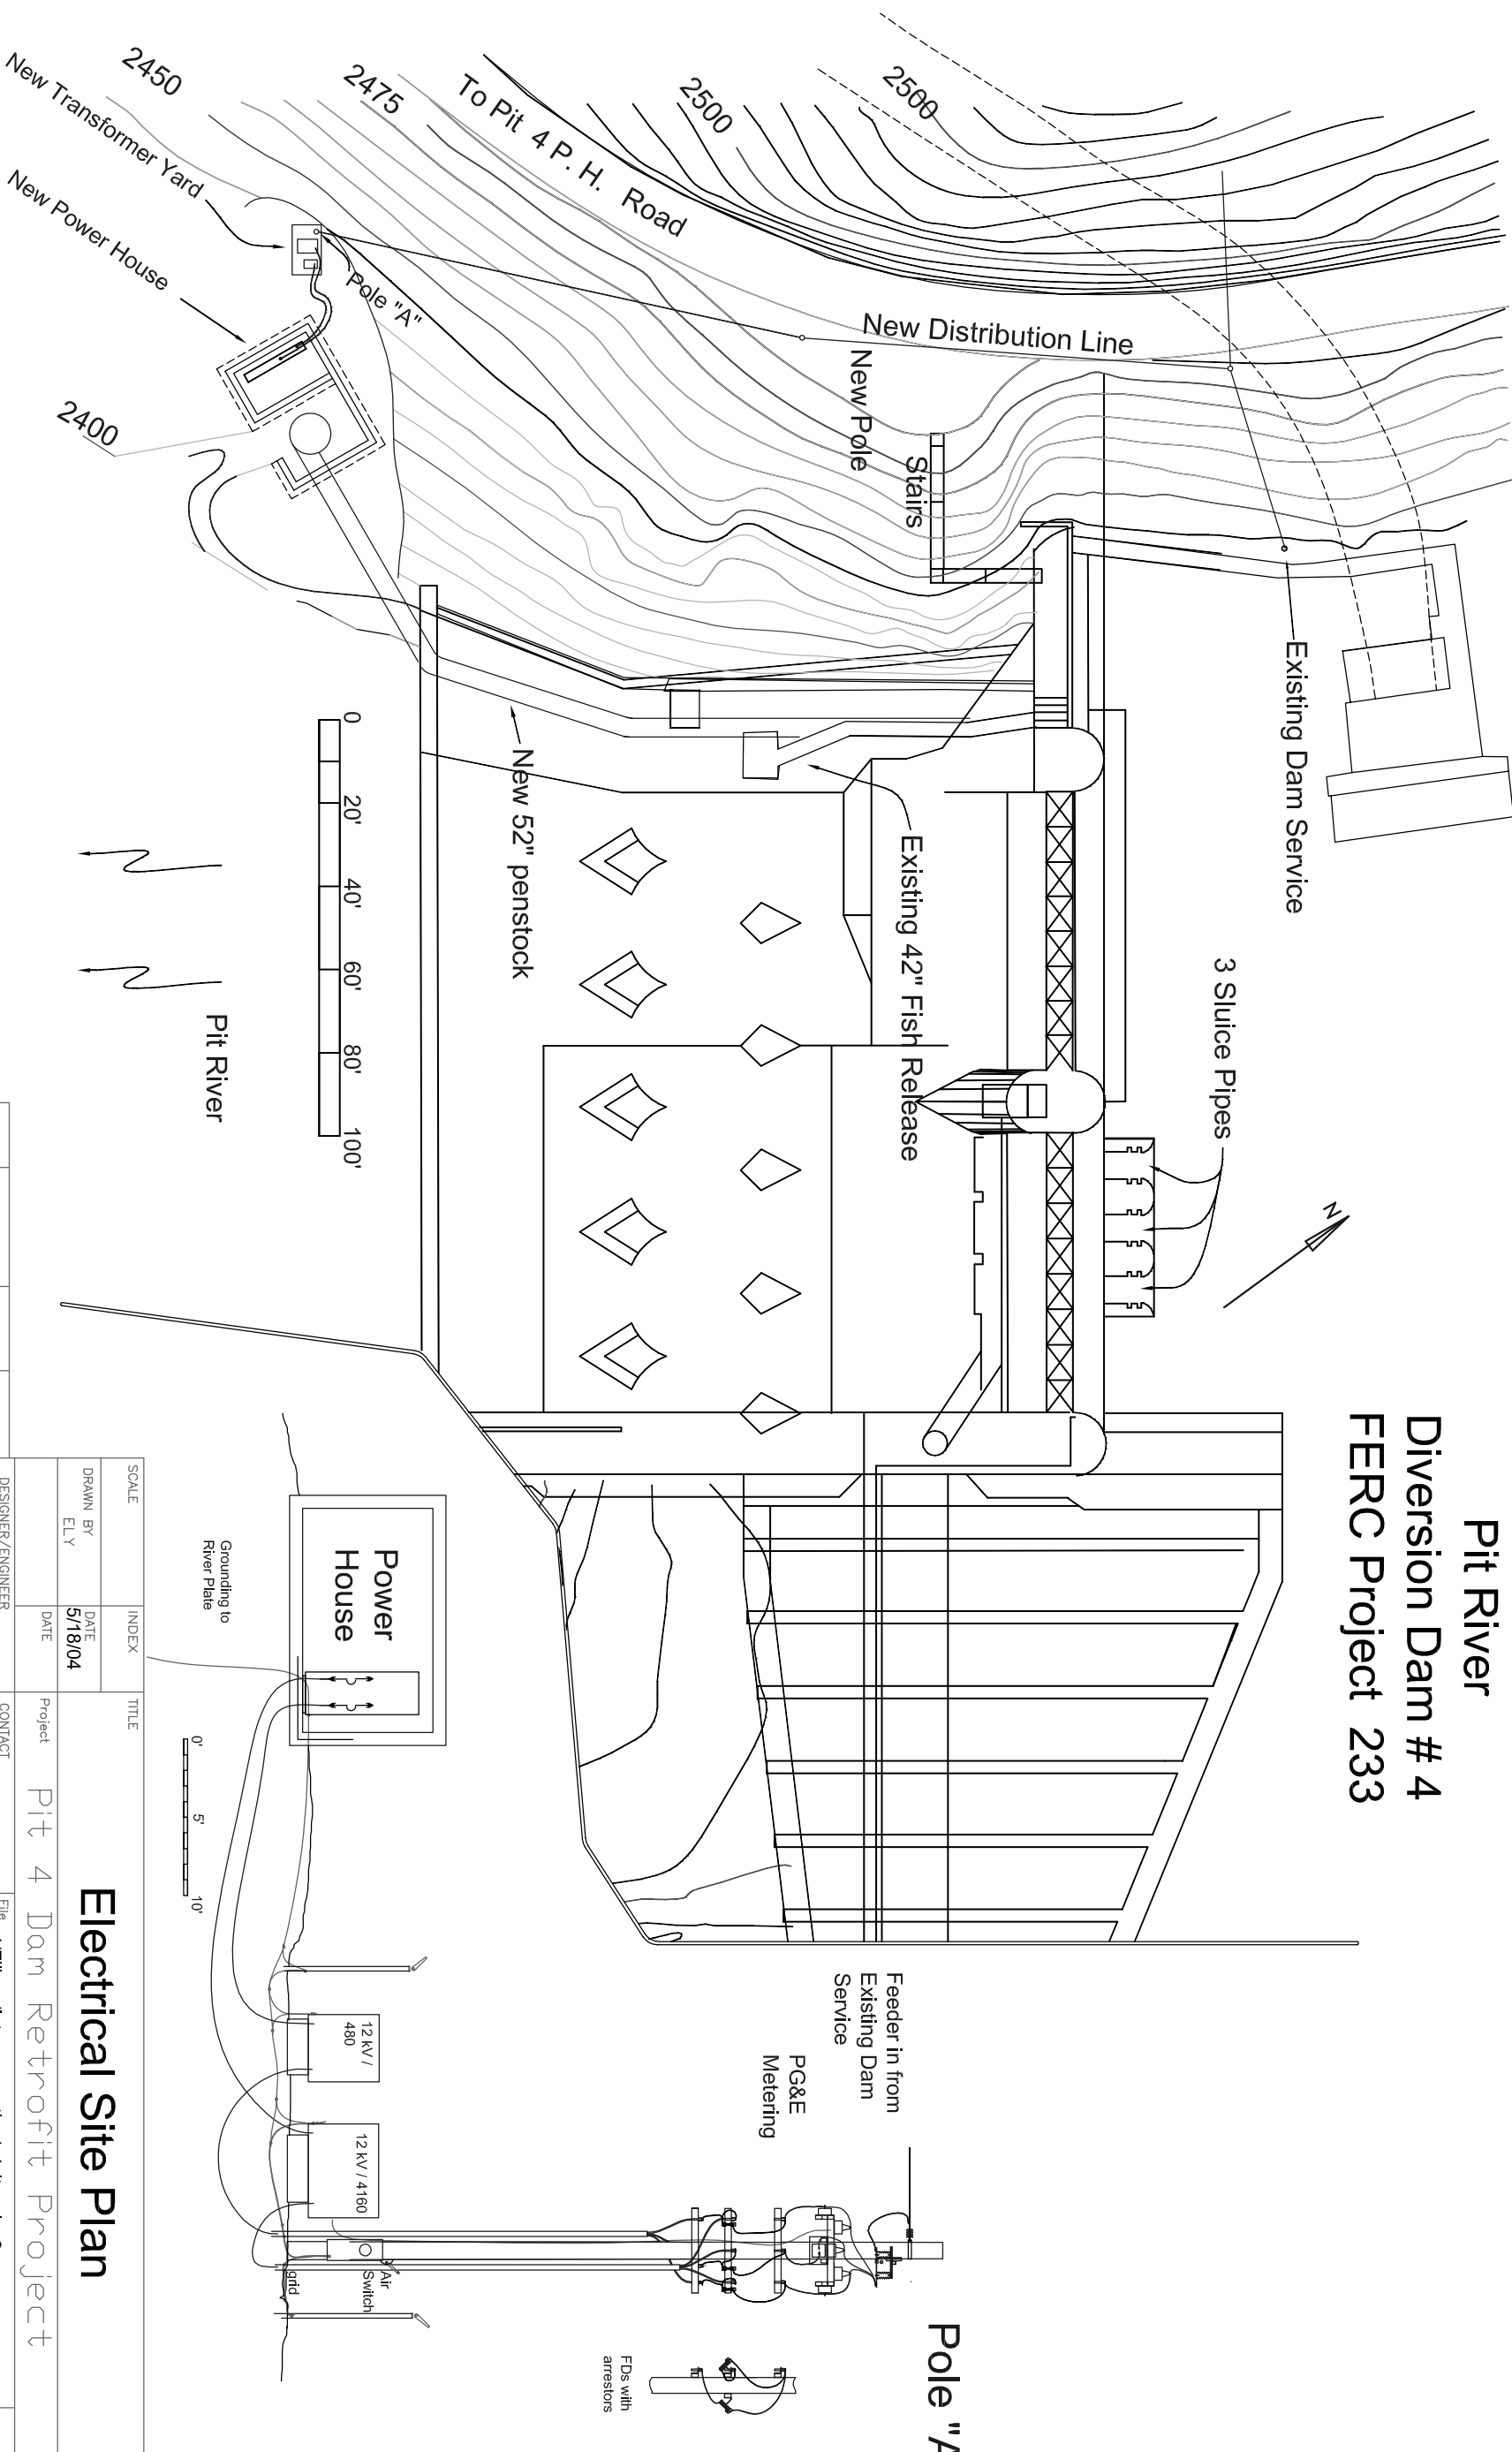

NO	DATE	REVISION	Drawn By	Revision Sent	Sent to	Media
0			J. Vard.	5/18/04		E-mail

SCALE	INDEX	TITLE
DRAWN BY ELY	DATE 5/18/04	<h2 style="margin: 0;">Electrical Site Plan</h2> <h3 style="margin: 0;">Pit 4 Dam Retrofit Project</h3>
DESIGNER/ENGINEER Staff	CONTACT 530 753-8864	
Davis Hydro 27264 Meadowbrook Drive DAVIS CALIFORNIA 95616		DWG NO <h1 style="margin: 0;">P4-E-2</h1>

REVISION
0