 

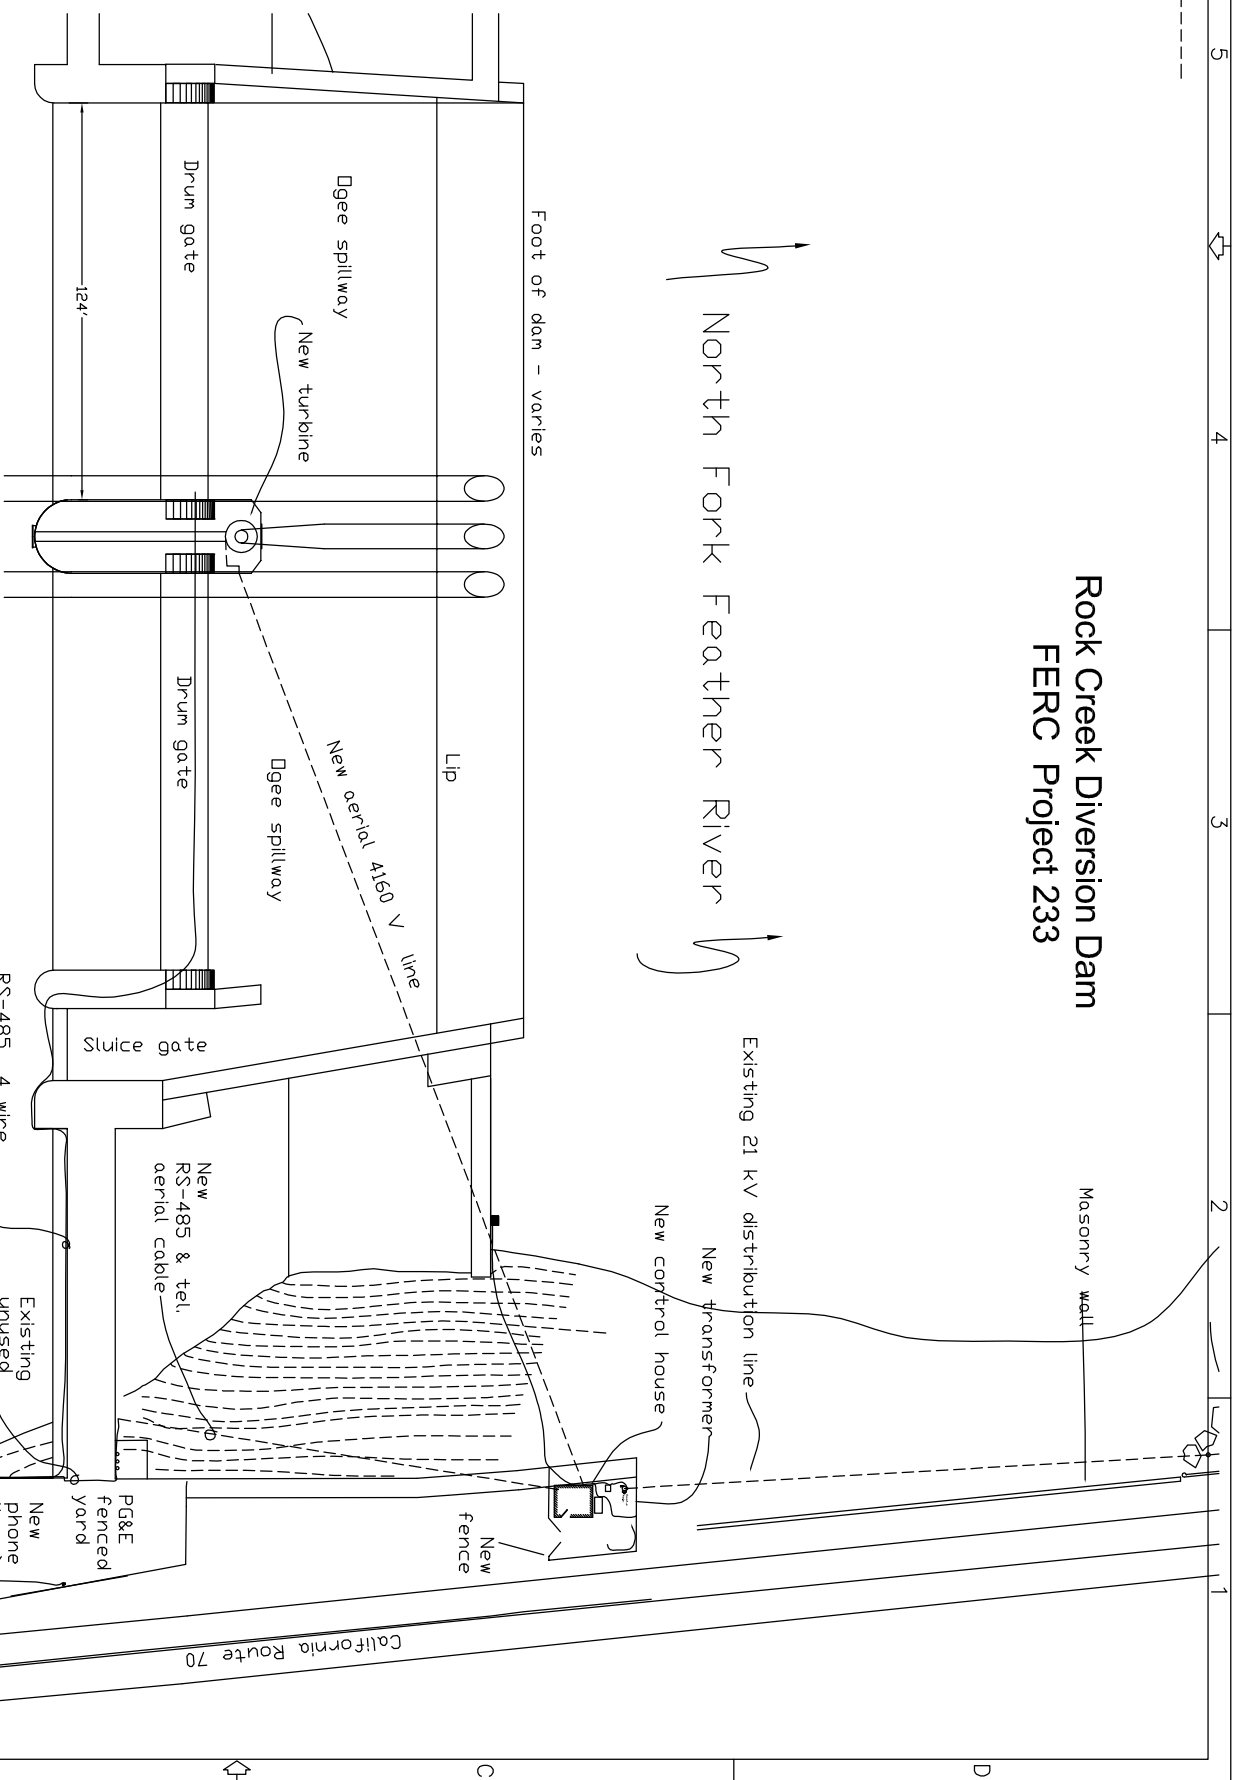
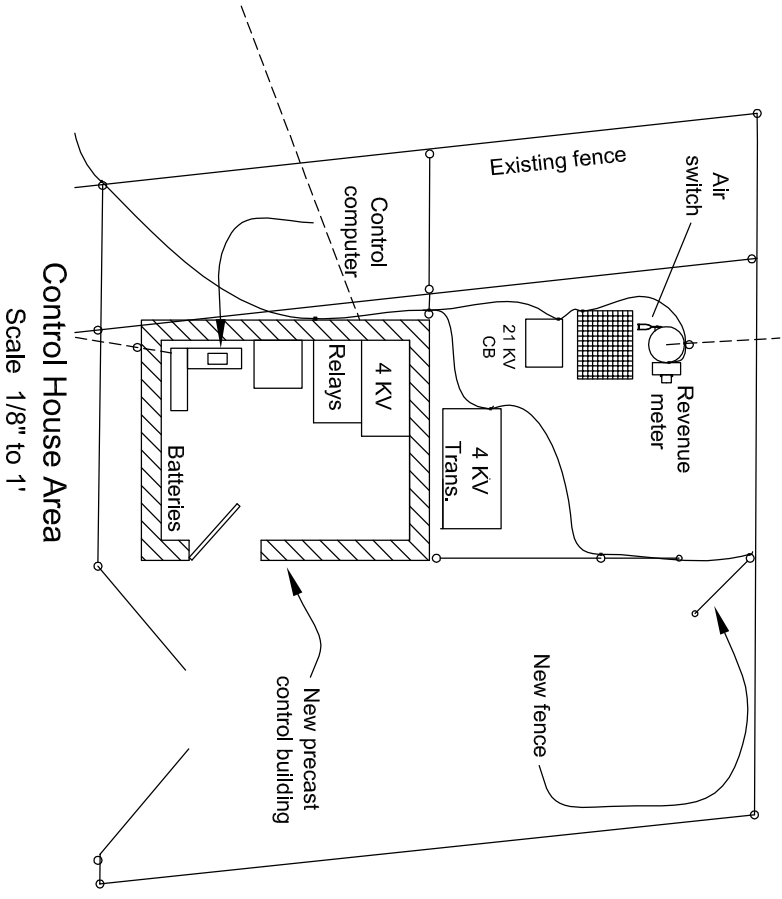
 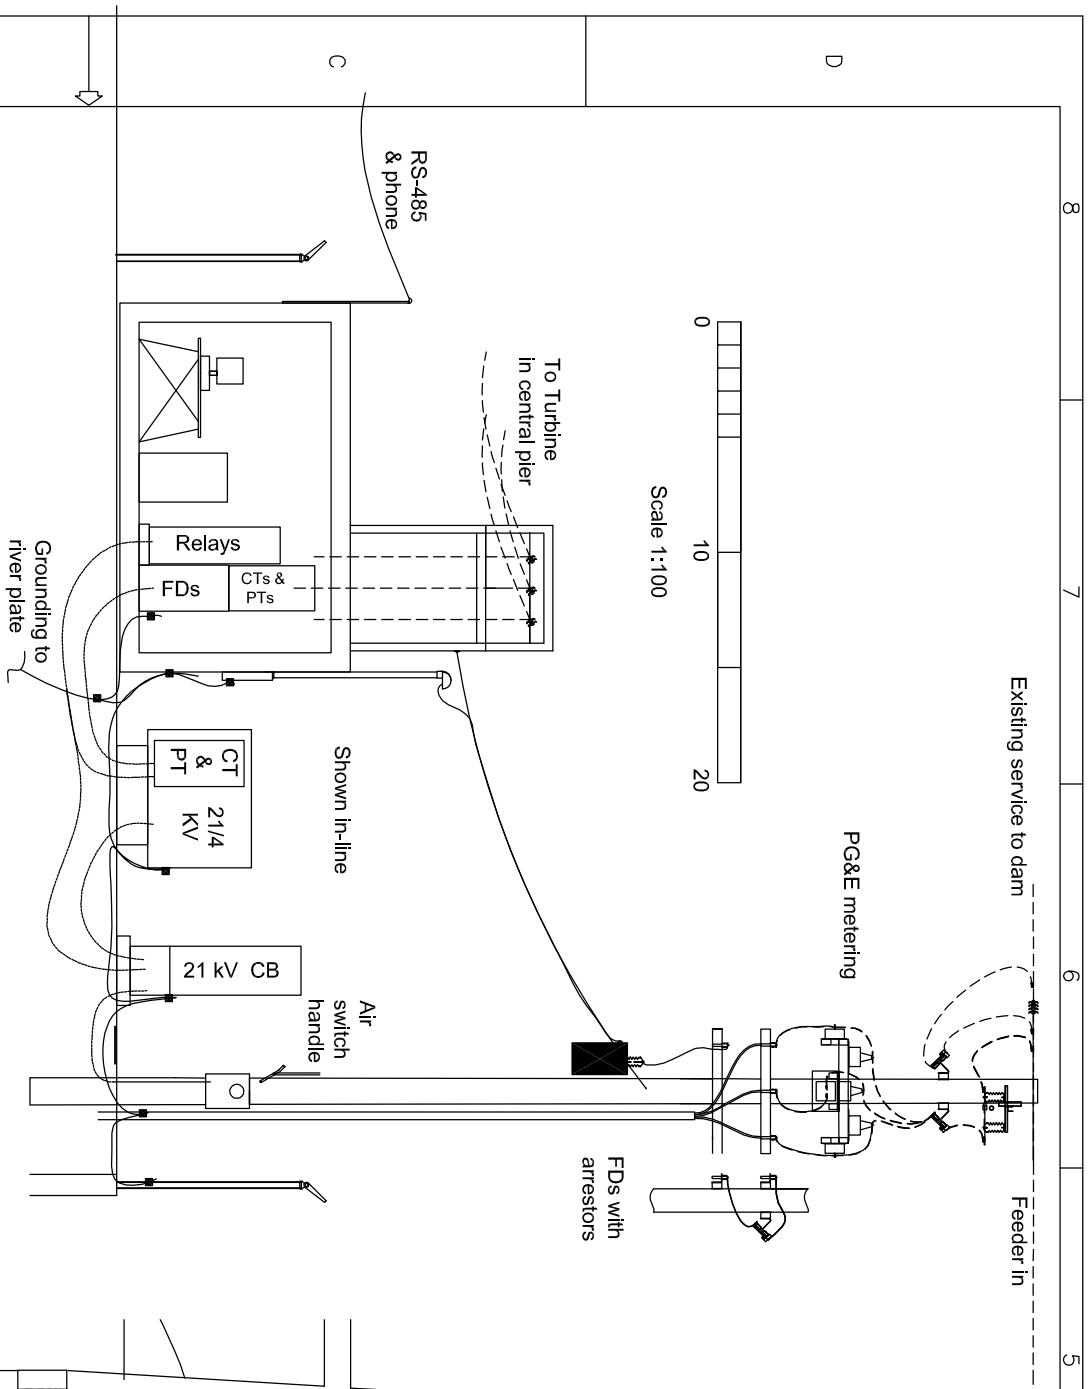


Rock Creek Diversion Dam FERC Project 233



Rock Creek Reservoir

SCALE	INDEX	TITLE
Various		Interconnection Site Plan
Drawn by ELY	5/6/05	
Original	5/5/04	Rock Creek Retrofit Project
DESIGNER/ENGINEER Staff	5/5/04	
CONTACT 530 753-8864	Project	Rock Creek Retrofit Project
DWG NO	530 753-8864	

2.0	J.Vard. PG&E	5/06/05	5/5/04
1.0	J.Vard. PG&E	3/12/04	EM/post
CHKD BY	Sent to	Archived	Medio

Davis Hydro		27264 Meadowbrook Drive DAVIS CALIFORNIA 95616	
RC - E - 4		2.0	